

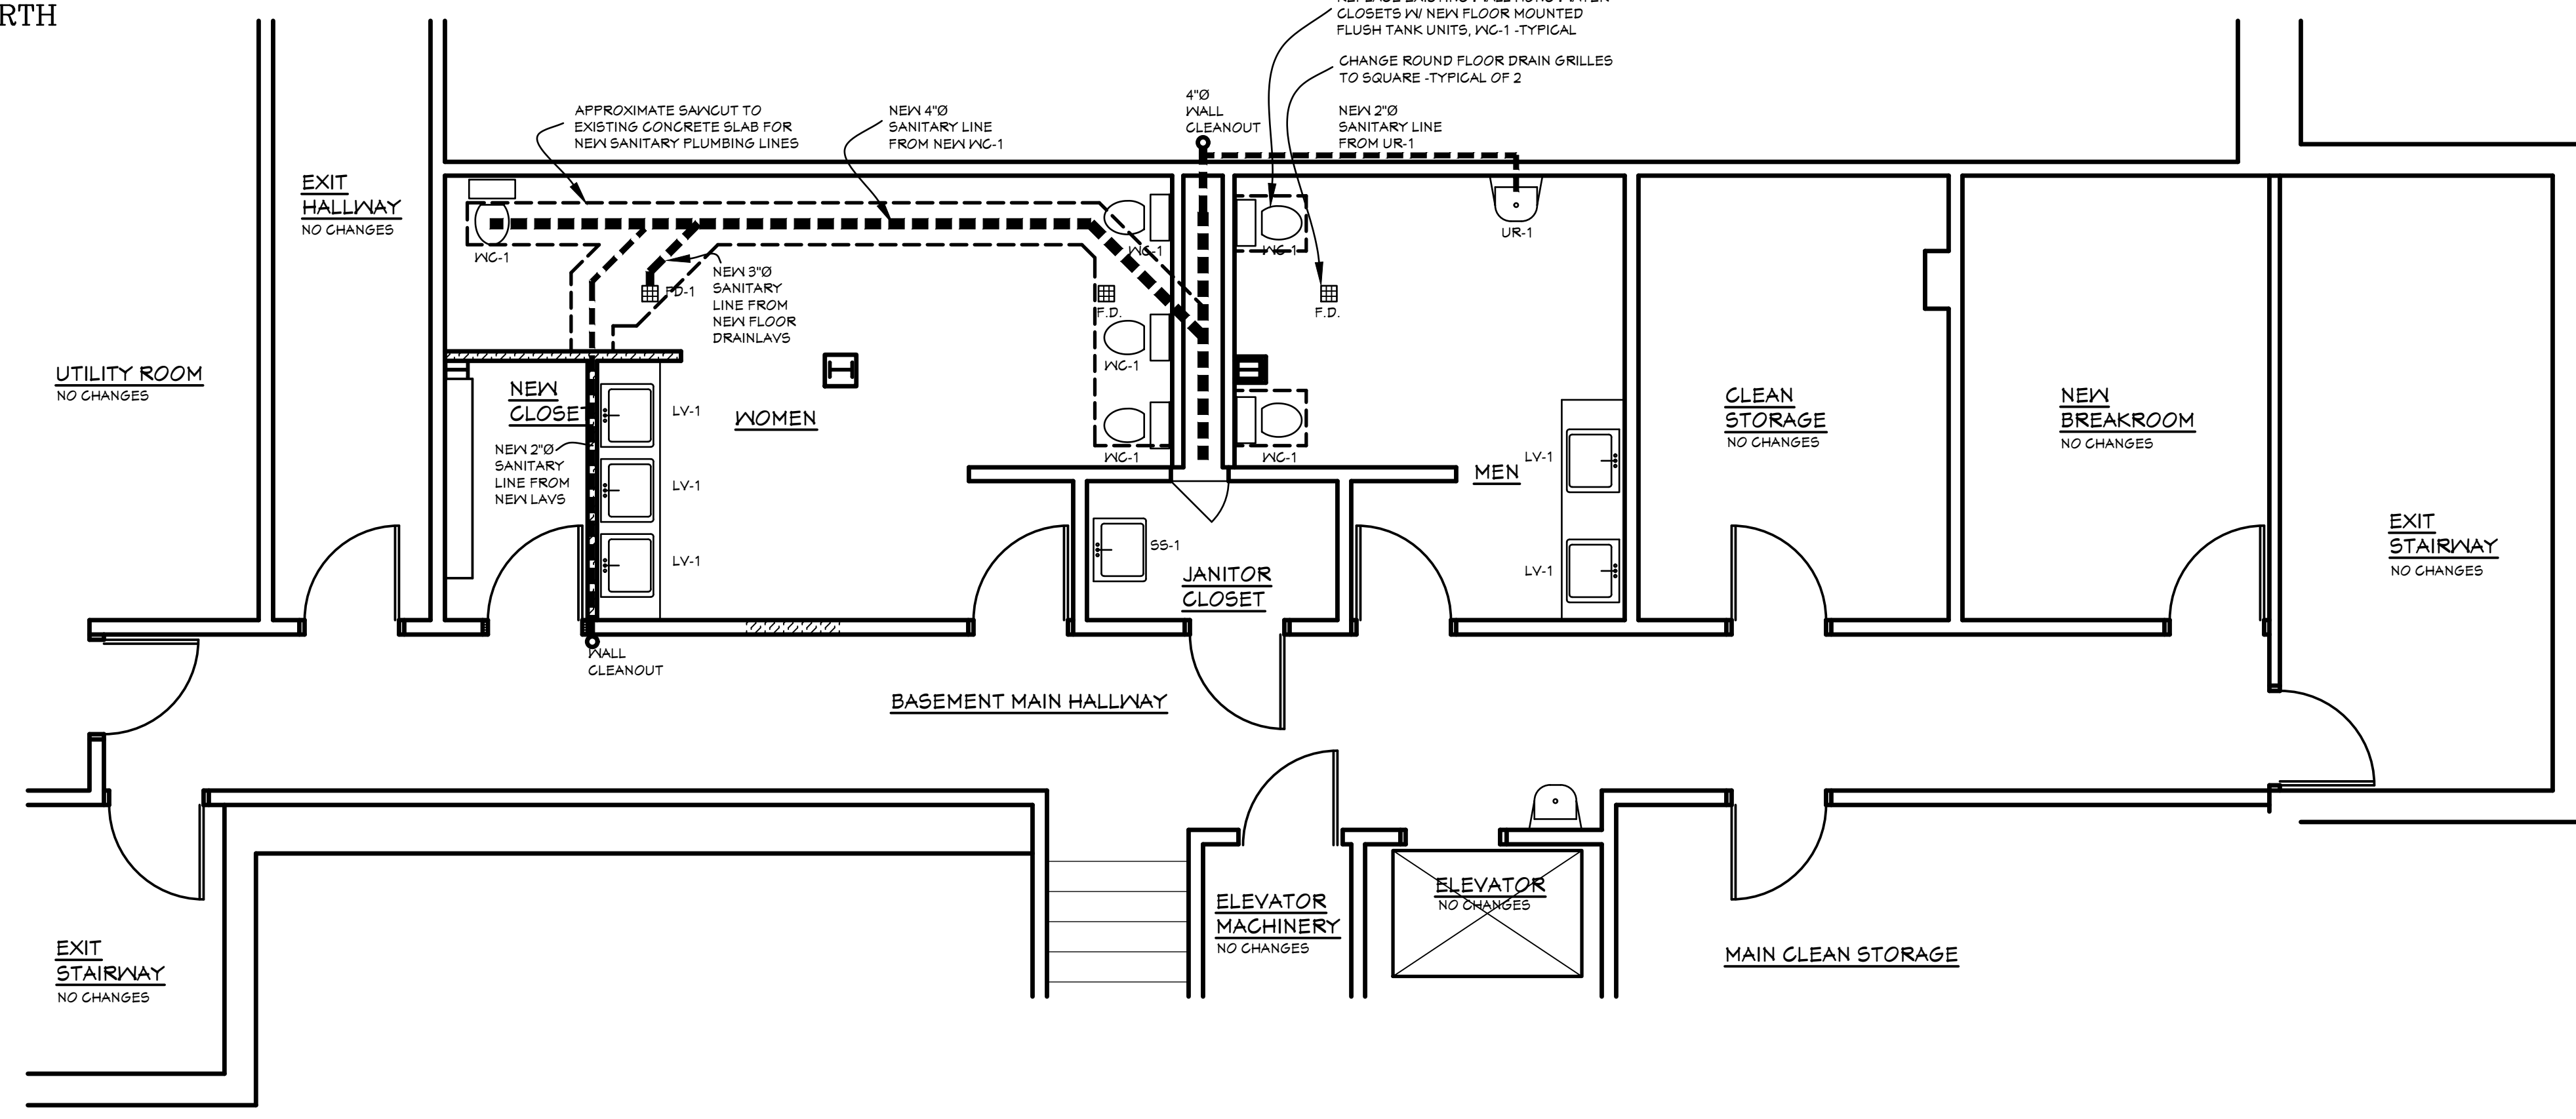


EXISTING PARTIAL BASEMENT PLUMBING PLAN

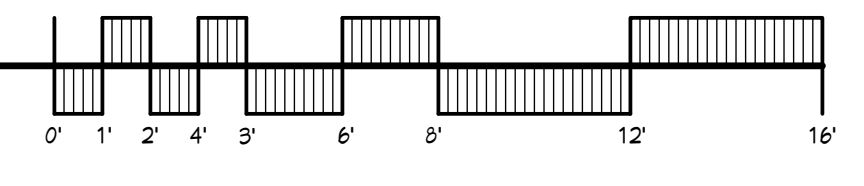

PROPOSED PARTIAL BASEMENT PLUMBING PLAN

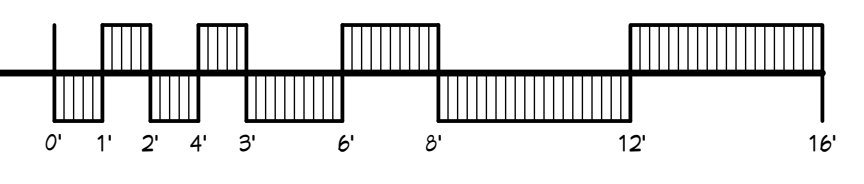

SEE A4.1 FOR ADDITIONAL PLUMBING INFORMATION

R. A. VanDerHeyden, Architect

410 East Main Street Genoa, Illinois 60135
 (815) 784 - 4833 * rvanarchitect@yahoo.com
 COPYRIGHT 2023 - ALL RIGHTS RESERVED

**RESTROOM REMODELING OF
 DEKALB COUNTY ADMIN. BUILDING**

110 E. Sycamore Street, Sycamore IL 60178
 Contact: Mr. Derek Hilland 815-784-7188

SEALED:
 PRELIMINARY: 9-28-2023
 PRELIMINARY: 10-19-2023
 CHECK SET: 11-1-2023
 PERMIT ISSUE: 12-6-2023
 LATEST REVISION:

DRAWN BY: RENE

SCALE: AS SHOWN

SHEET
P2.1
 OF
 6